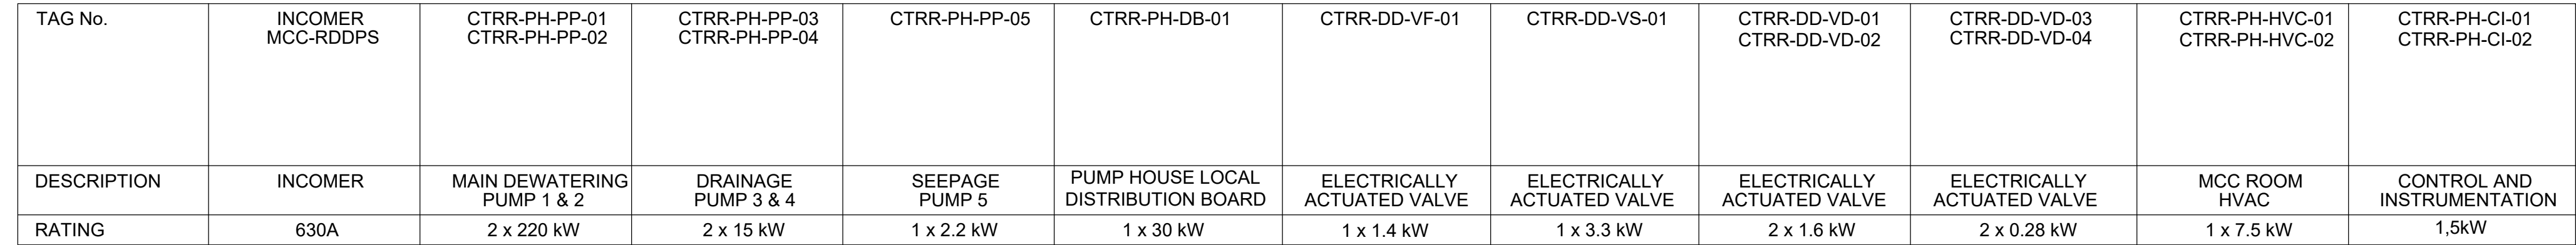


1. REFER TO DRAWING P07551-E-SH-001 FOR LEGEND.
2. CASCADE SYSTEM LABELLING TO BE APPLIED

[illegible]

Acceptance	Name	Signature	Date
Senior Engineer Transnet			
Project Engineer Transnet			
Managing Contractor WSP			

"The Employer may use and copy the Contractor's design for any purpose connected with construction, use, alteration or demolition of the works unless otherwise stated in the Works Information and for other purposes as stated in the Works Information."

Copyright reserved

REVISION SCHEDULE				
No	DATE	DESCRIPTION	DRW	CHK
0	01/04/22	Issued for Discussion	SCS	WMW
1	04/04/22	Add cable feed to VFC3	SCS	WMW
2	03/05/22	Updated Actuated Valve Sections & Drainage Pump Feeders	SCS	WMW
3	16/05/22	For Approval	SCS	WMW
4	06/06/22	Pump room ventilation supply moved	SCS	WMW
5	08/07/22	Issued for Construction	SCS	WMW
6	15/07/22	Copyright updated	SCS	WMW
7	02/09/22	Revise Drainage Pump 3.4 rating to 15kW	SCS	WMW
8	14/09/22	VF-02 removed DB-01. Added VD-03 & VD-04 rating updated	SCS	WMW

CONSULTING ENGINEER		
	W Synman 20050166	15/09/2022
SIGNATURE	PR No	DATE
CLIENT		
_____	_____	_____
SIGNATURE	NAME	DATE
DESIGNED	DRAWN	CHECKED
WMS	SCS	WS
_____	_____	_____

CONSULTANT

iXengineers
Infrastructure Excellence

31 Allen Drive | Loventstein | Cape Town |
7530 | South Africa
Tel: +27 (0) 21 912 3000
www.ixengineers.co.za

H&I

Haw & Inglis
Hillcrest Farm,
Tygerberg Valley Rd,
Durbanville, Cape Town
7550

CLIENT



TRANSNET

PROJECT

ROBINSON DRY DOCK
DEWATERING SYSTEMS

DRAWING DESCRIPTION

PROPOSED MCC-RDDPS
SINGLE LINE DIAGRAM

SCALE FOR REDUCED PLAN		
 50mm on ORIGINAL PLAN		
DATE	SCALE	ORIGINAL SIZE
11/02/2022	NTS	A1
DRAWING NUMBER		REV
P07551-E-SH-005		9