


NOTES.

1. REFER TO DRAWING P07551-E-SH-001 FOR LEGEND.
2. CASCADE SYSTEM LABELLING TO BE APPLIED

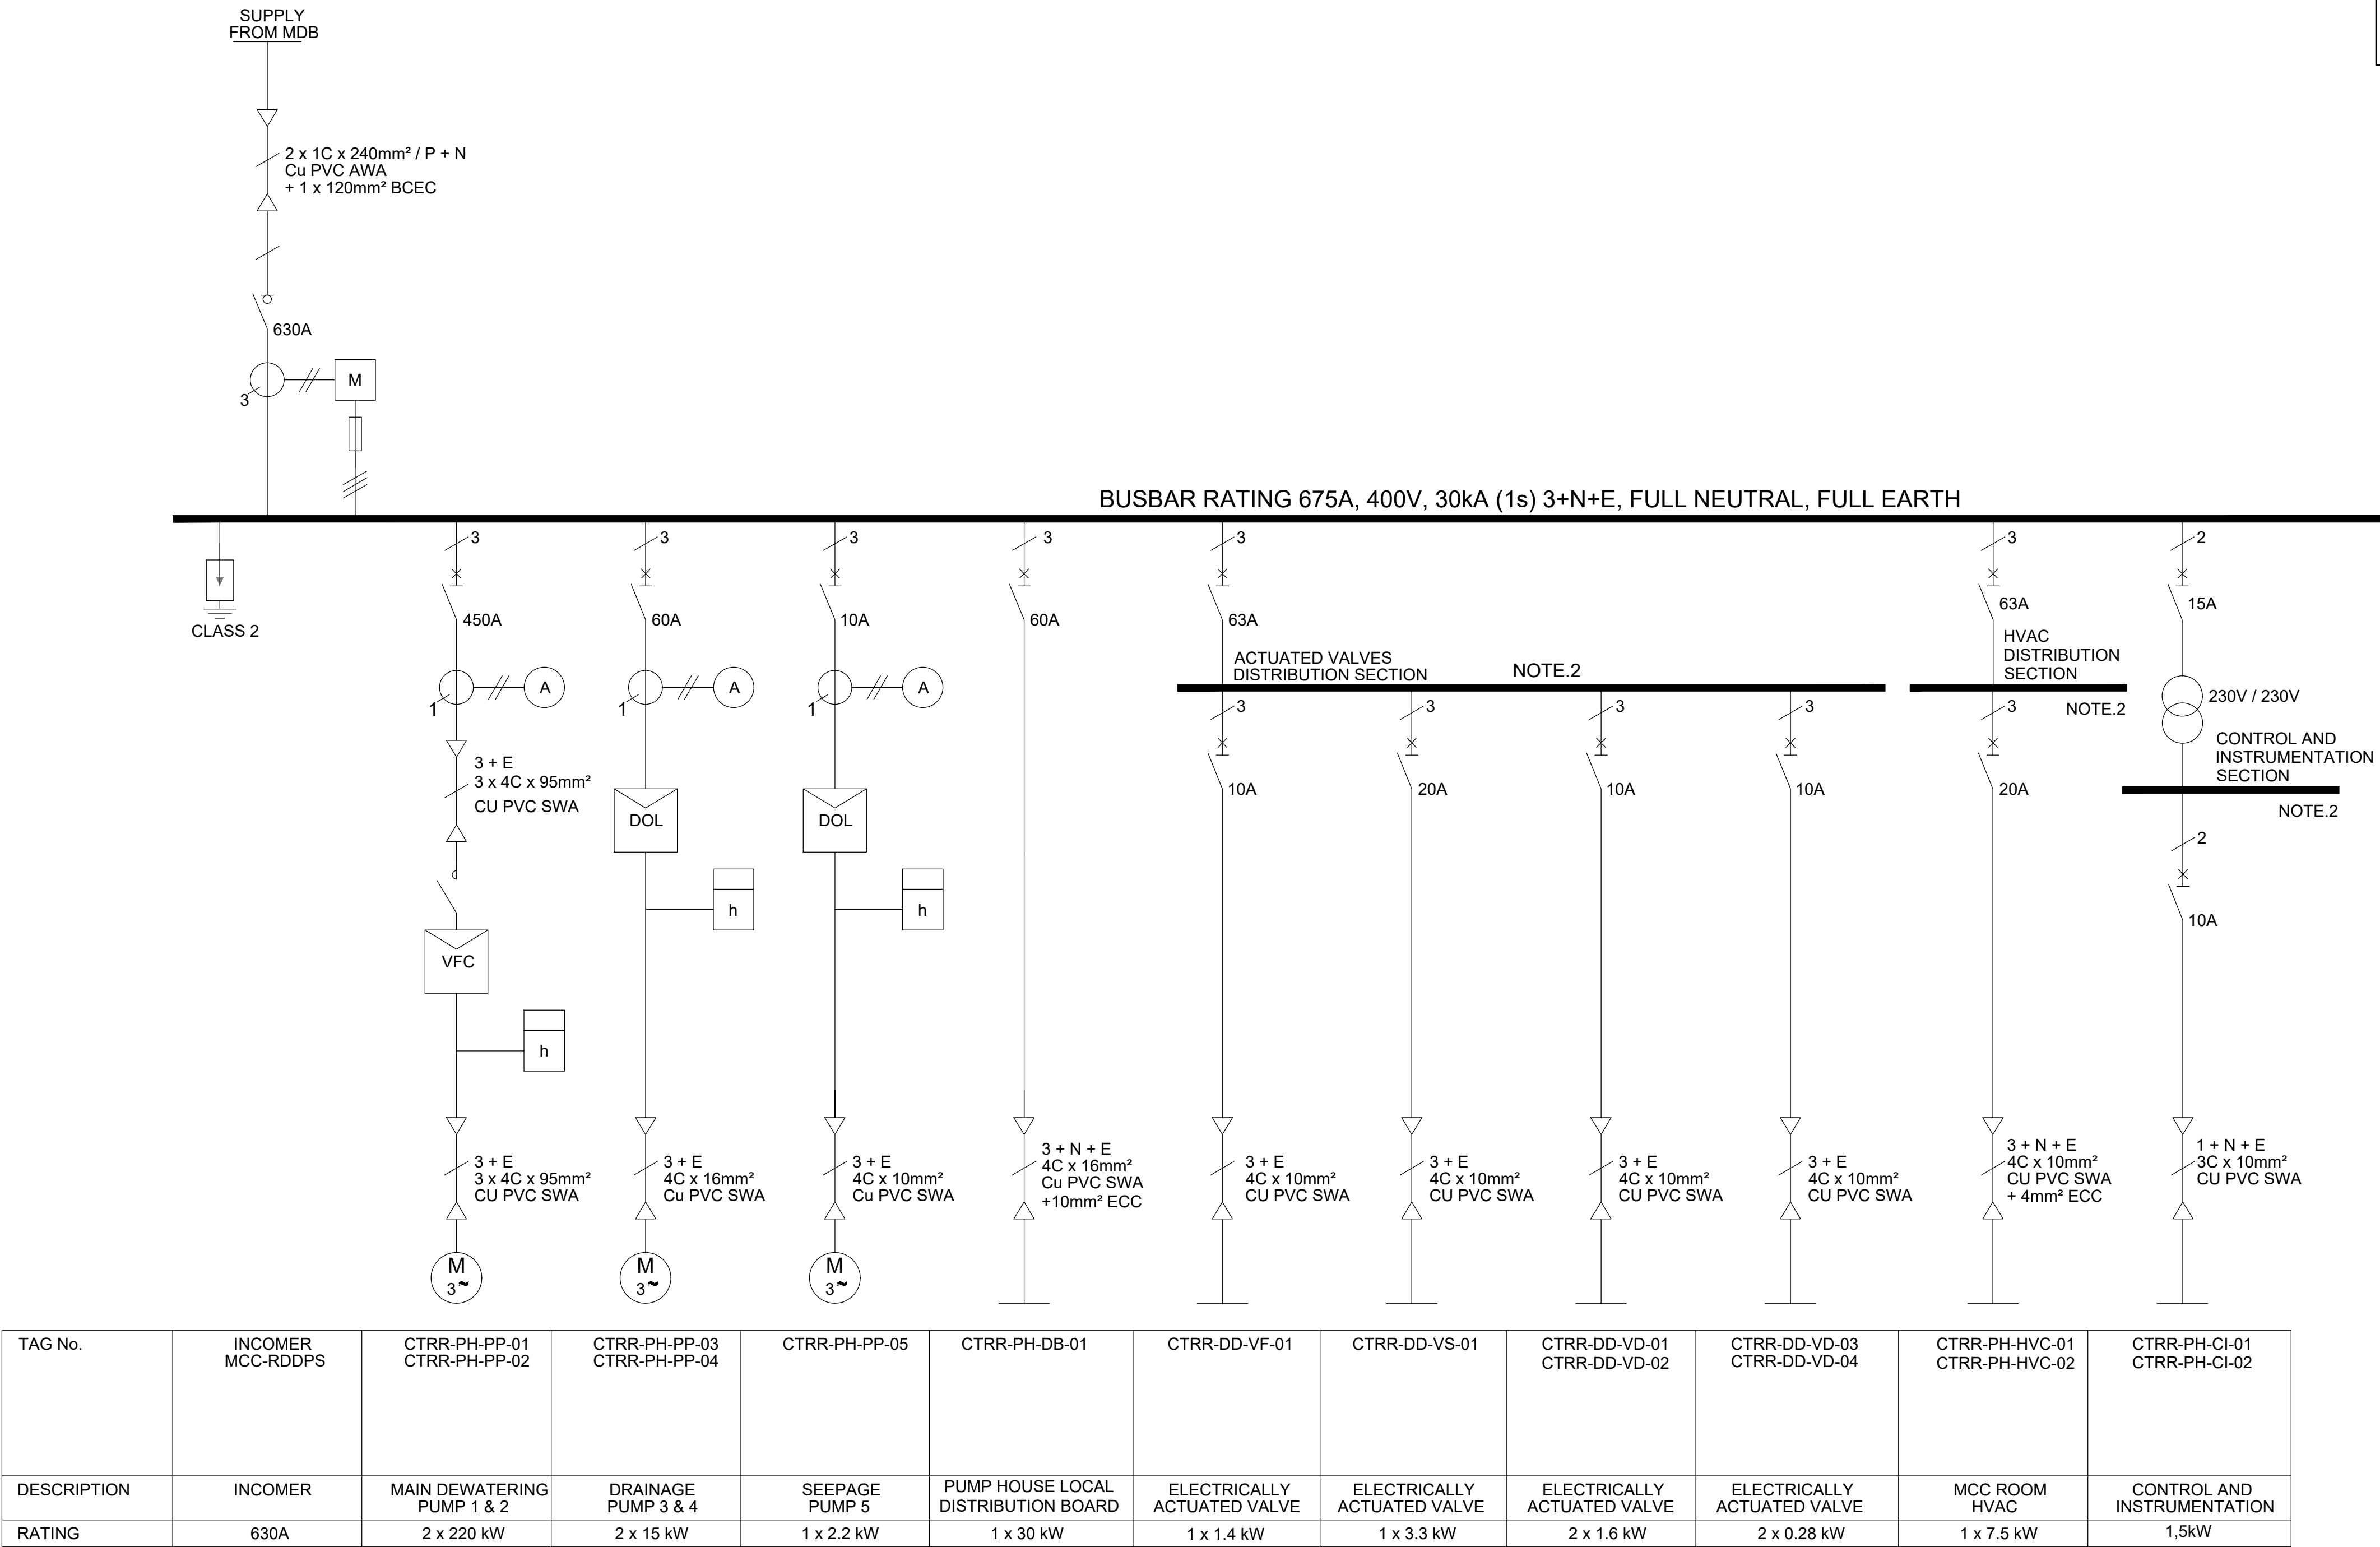

Acceptance	Name	Signature	Date
Senior Engineer Transnet			
Project Engineer Transnet			
Managing Contractor WSP			

"The Employer may use and copy the Contractor's design for any purpose connected with construction, use, alteration or demolition of the works unless otherwise stated in the Works Information and for other purposes as stated in the Works Information."

All dimensions must be verified on site before the works commence. Refer any discrepancies to the Engineer.

Copyright reserved

REVISION SCHEDULE

No	DATE	DESCRIPTION	DRW	CHK
0-2	01/04/22	Issued for Discussion	SCS	WMS
3-4	16/05/22	For Approval	SCS	WMS
5-6	08/07/22	Issued for Construction	SCS	WMS
7	15/07/22	Revise Drainage Pump 3 & 4 rating to 15kW	SCS	WMS
8	14/09/22	VF-02 Removed DB-01, Added VD-03 & VD-04 rating updated	SCS	WMS
9	15/09/22	Ammeter for circuit DB-01 removed	SCS	WMS

CONSULTING ENGINEER

SIGNATURE	W Snyman 20050166	15/09/2022
PR No		DATE
CLIENT		
SIGNATURE	NAME	DATE
DESIGNED	DRAWN	CHECKED
WMS	SCS	WS
SIGNATURE	NAME	DATE

CONSULTANT



31 Allen Drive | Loovestein | Cape Town | 7530 | South Africa
Tel: +27 (0) 21 912 3000
www.ixengineers.co.za



Hav & Inglis
Hillcrest Farm,
Tygerberg Valley Rd,
Durbanville, Cape Town
7550

CLIENT



TRANSNET

PROJECT

ROBINSON DRY DOCK
DEWATERING SYSTEMS

DRAWING DESCRIPTION

PROPOSED MCC-RDDPS
SINGLE LINE DIAGRAM

SCALE FOR REDUCED PLAN



DATE	SCALE	ORIGINAL SIZE
11/02/2022	NTS	A1

DRAWING NUMBER	REV
P07551-E-SH-005	9