
 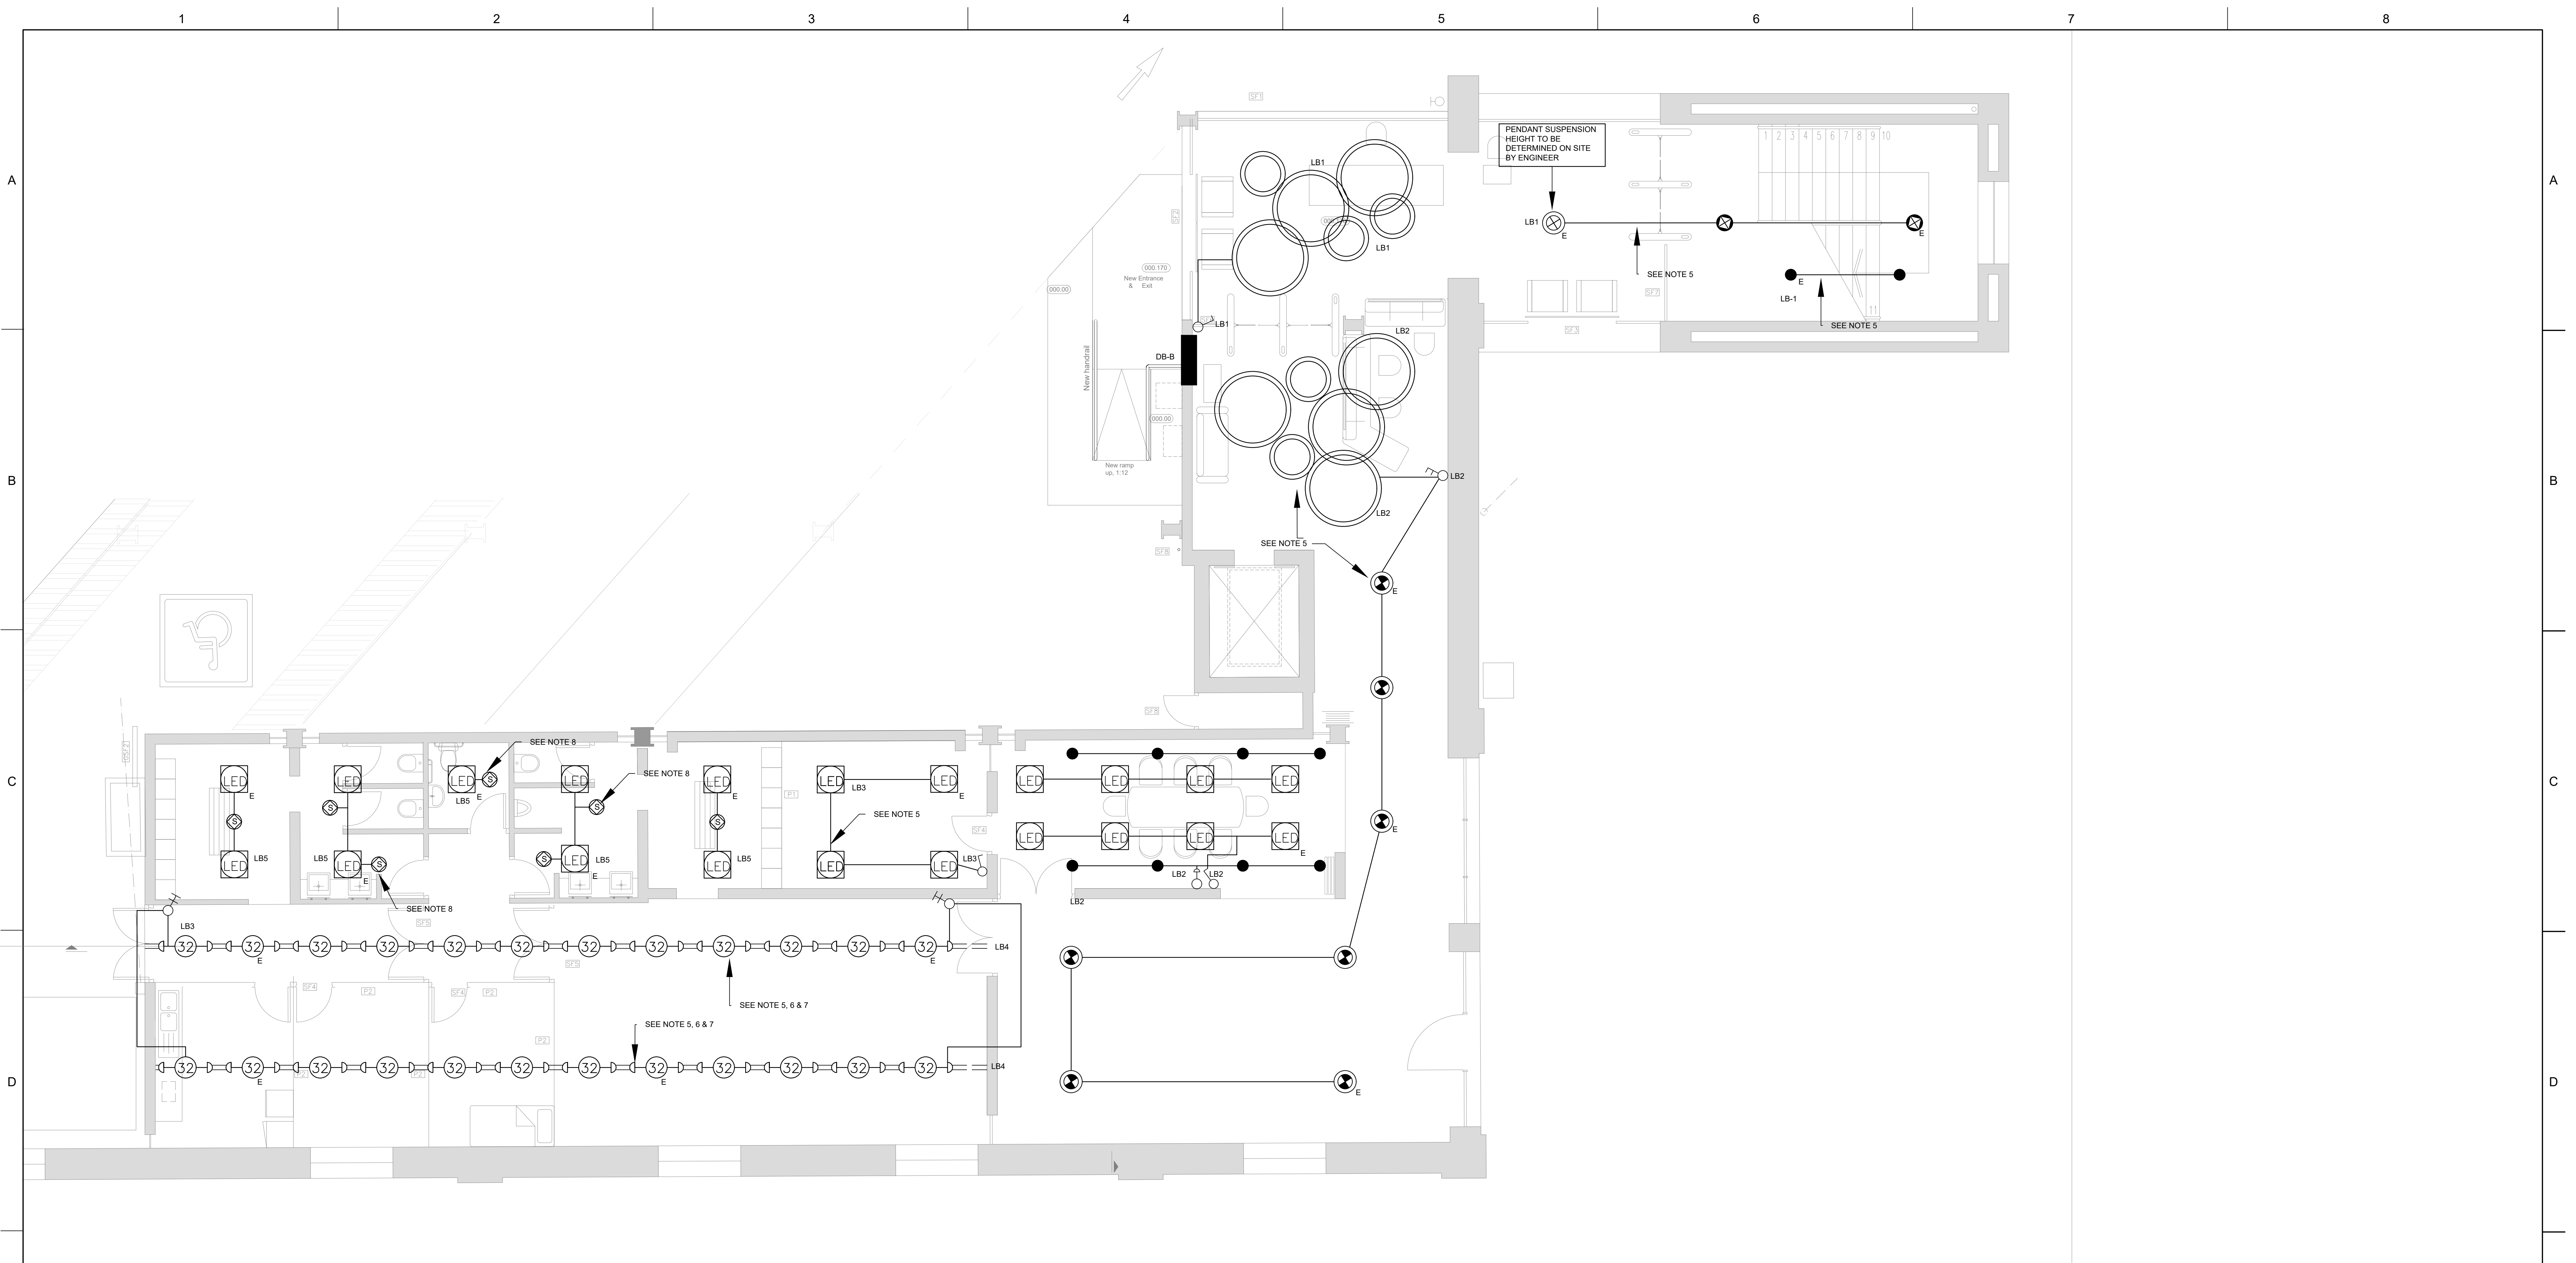




 **GROUND FLOOR RECEPTION
LIGHTING LAYOUT**
Scale 1:50

E	OCCUPANCY SENSOR TO COMPLY WITH TPD-A02-OSENSORPERFSPEC 32W, 4000K, WHITE SURFACE DECORATIVE LUMINAIRE WITH INTEGRATED MOVEMENT SENSOR TO CONFORM WITH TPD-A06-LUM01PERFSPEC (SUSPENDED 3M AFL) 32W, 4000K, EMG 15MIN, WHITE SURFACE DECORATIVE LUMINAIRE WITH INTEGRATED MOVEMENT SENSOR TO CONFORM WITH TPD-A06-LUM01PERFSPEC (SUSPENDED 3M AFL) 7W, 4000K, MINI RECESSED DOWNLIGHTER TO CONFORM WITH TPD-A09-LUM02PERFSPEC 7W, 4000K, EMG 15MIN, MINI RECESSED DOWNLIGHTER TO CONFORM WITH TPD-A09-LUM02PERFSPEC 25W, 600MM, 4000K LED SUPER DOME PENDANT LUMINAIRE TO COMPLY WITH TPD-A10-LUM03PERFSPEC 26W, 600MM, 4000K, EMG 15MIN LED SUPER DOME PENDANT LUMINAIRE TO COMPLY WITH TPD-A10-LUM03PERFSPEC 30W, 4000K, 600x600 RECESSED LUMINAIRE TO CONFORM WITH TPD-A11-LUM01PERFSPEC 30W, 4000K, EMG 15MIN, 600x600 RECESSED LUMINAIRE TO CONFORM WITH TPD-A11-LUM01PERFSPEC 23W, 4000K LARGE SURFACE DOWNLIGHTER TO CONFORM WITH TPD-A09-LUM03PERFSPEC 23W, 4000K EMG 15MIN, LARGE SURFACE DOWNLIGHTER TO CONFORM WITH TPD-A09-LUM03PERFSPEC 75W, 1200MM, 4000K, EMG 15MIN LED SUPER DOME PENDANT LUMINAIRE TO COMPLY WITH TPD-A10-LUM03PERFSPEC 32W, 800MM, 4000K LED DECORATIVE PENDANT LUMINAIRE TO COMPLY WITH TPD-A10-LUM02PERFSPEC 61W, 1500MM, 4000K, EMG 15MIN, LED DECORATIVE PENDANT LUMINAIRE TO COMPLY WITH TPD-A10-LUM02PERFSPEC ELECTRICAL DISTRIBUTION BOARD H-O TWO LEVER TWO WAY LIGHT SWITCH 4X2 GRAPHITE TO COMPLY WITH TPD-A01-SDPERFSPEC L-O ONE LEVER ONE WAY LIGHT SWITCH 4X2 GRAPHITE TO COMPLY WITH TPD-A01-SDPERFSPEC +O TWO LEVER ONE WAY LIGHT SWITCH 4X2 GRAPHITE TO COMPLY WITH TPD-A01-SDPERFSPEC +OO 16A DIMMER LIGHT SWITCH 4X2 GRAPHITE TO COMPLY WITH TPD-A01-SDPERFSPEC 1. THIS DRAWING IS FOR ELAP ONLY. 2. A CERTIFICATE OF COMPLIANCE TO BE COMPLETED BY CONTRACTOR ON COMPLETION OF WORK. 3. DO NOT SCALE DRAWING - ONLY DIMENSIONS SHOWN TO BE USED. 4. THE CONTRACTOR SHALL VERIFY ALL CONDITIONS, DIMENSIONS AND LEVELS ON THE SITE AND NOTIFY THE NEC SUPERVISOR OF ANY VARIATIONS BEFORE CONSTRUCTION. 5. ALL EXISTING LIGHTING CIRCUITS TO BE RETAINED AND RE-USED 6. EXISTING UNISTRUT TO BE RETAINED AND RE-USED. 7. THE CONTRACTOR SHALL TEST AND VERIFY ALL ELECTRICAL CIRCUITS AT DB-B. THE CONTRACTOR SHALL ALSO RELABEL DB-B AND LABEL ALL SOCKET OUTLETS, ISOLATORS AND LIGHT SWITCHES INDICATING RELEVANT CIRCUIT NUMBERS. 8. ALL BATHROOM SENSORS TO HAVE 30-MINUTE DELAY		F
F	DRAWING NO. REFERENCE DRAWINGS NOTES 1. DO NOT SCALE DRAWING - ONLY DIMENSIONS SHOWN TO BE USED. 2. THE CONTRACTOR SHALL VERIFY ALL CONDITIONS, DIMENSIONS AND LEVELS ON THE SITE AND NOTIFY THE NEC SUPERVISOR OF ANY VARIATIONS BEFORE CONSTRUCTION. 3. ALL LEVELS ARE IN METERS TO MEAN SEA LEVEL ISSUED FOR TENDER NO. DESCRIPTION BY CHKD APPD DATE REVISIONS The Document including all design and information herein is Confidential Intellectual Property of Transnet Copyright and all other rights are reserved by Transnet. This Document may only be used for its intended purpose. PRIVATE OPERATOR LOGO CONSULTANTS ENGINEERS LOGO CONTRACTOR / CONSULTANT TITLE NAME SIGN DATE DRAWN ZD PM SS 27 07 2026 CHECKED - PM - - DESIGNED - ZD - - CHECKED - SS - - TRANSNET NATIONAL PORTS AUTHORITY TITLE NAME SIGN DATE DRAWN ZD PP CS 19 09 25 CHECKED PM CS 19 09 25 DESIGNED ZD PP CS 19 09 25 CHECKED SS CS 19 09 25 PR. ENG. / PR. TECH./PR. ARCH NAME XX DATE SIGNATURE XXXXX REG. NUMBER XXXXX PR. ENG. / PR. TECH./PR. ARCH NAME SUDESH SEKHARVAL DATE 27 07 26 SIGNATURE  REG. NUMBER 200870120 PORT OF DURBAN REFURBISHMENT TO QUEENS WAREHOUSE GROUND FLOOR ELECTRICAL RECEPTION LIGHTING LAYOUT PROJECT DRG. NO. XDN.E.0037 - 1 - 100 - E - LA - 0001 - 01 REV. E		