


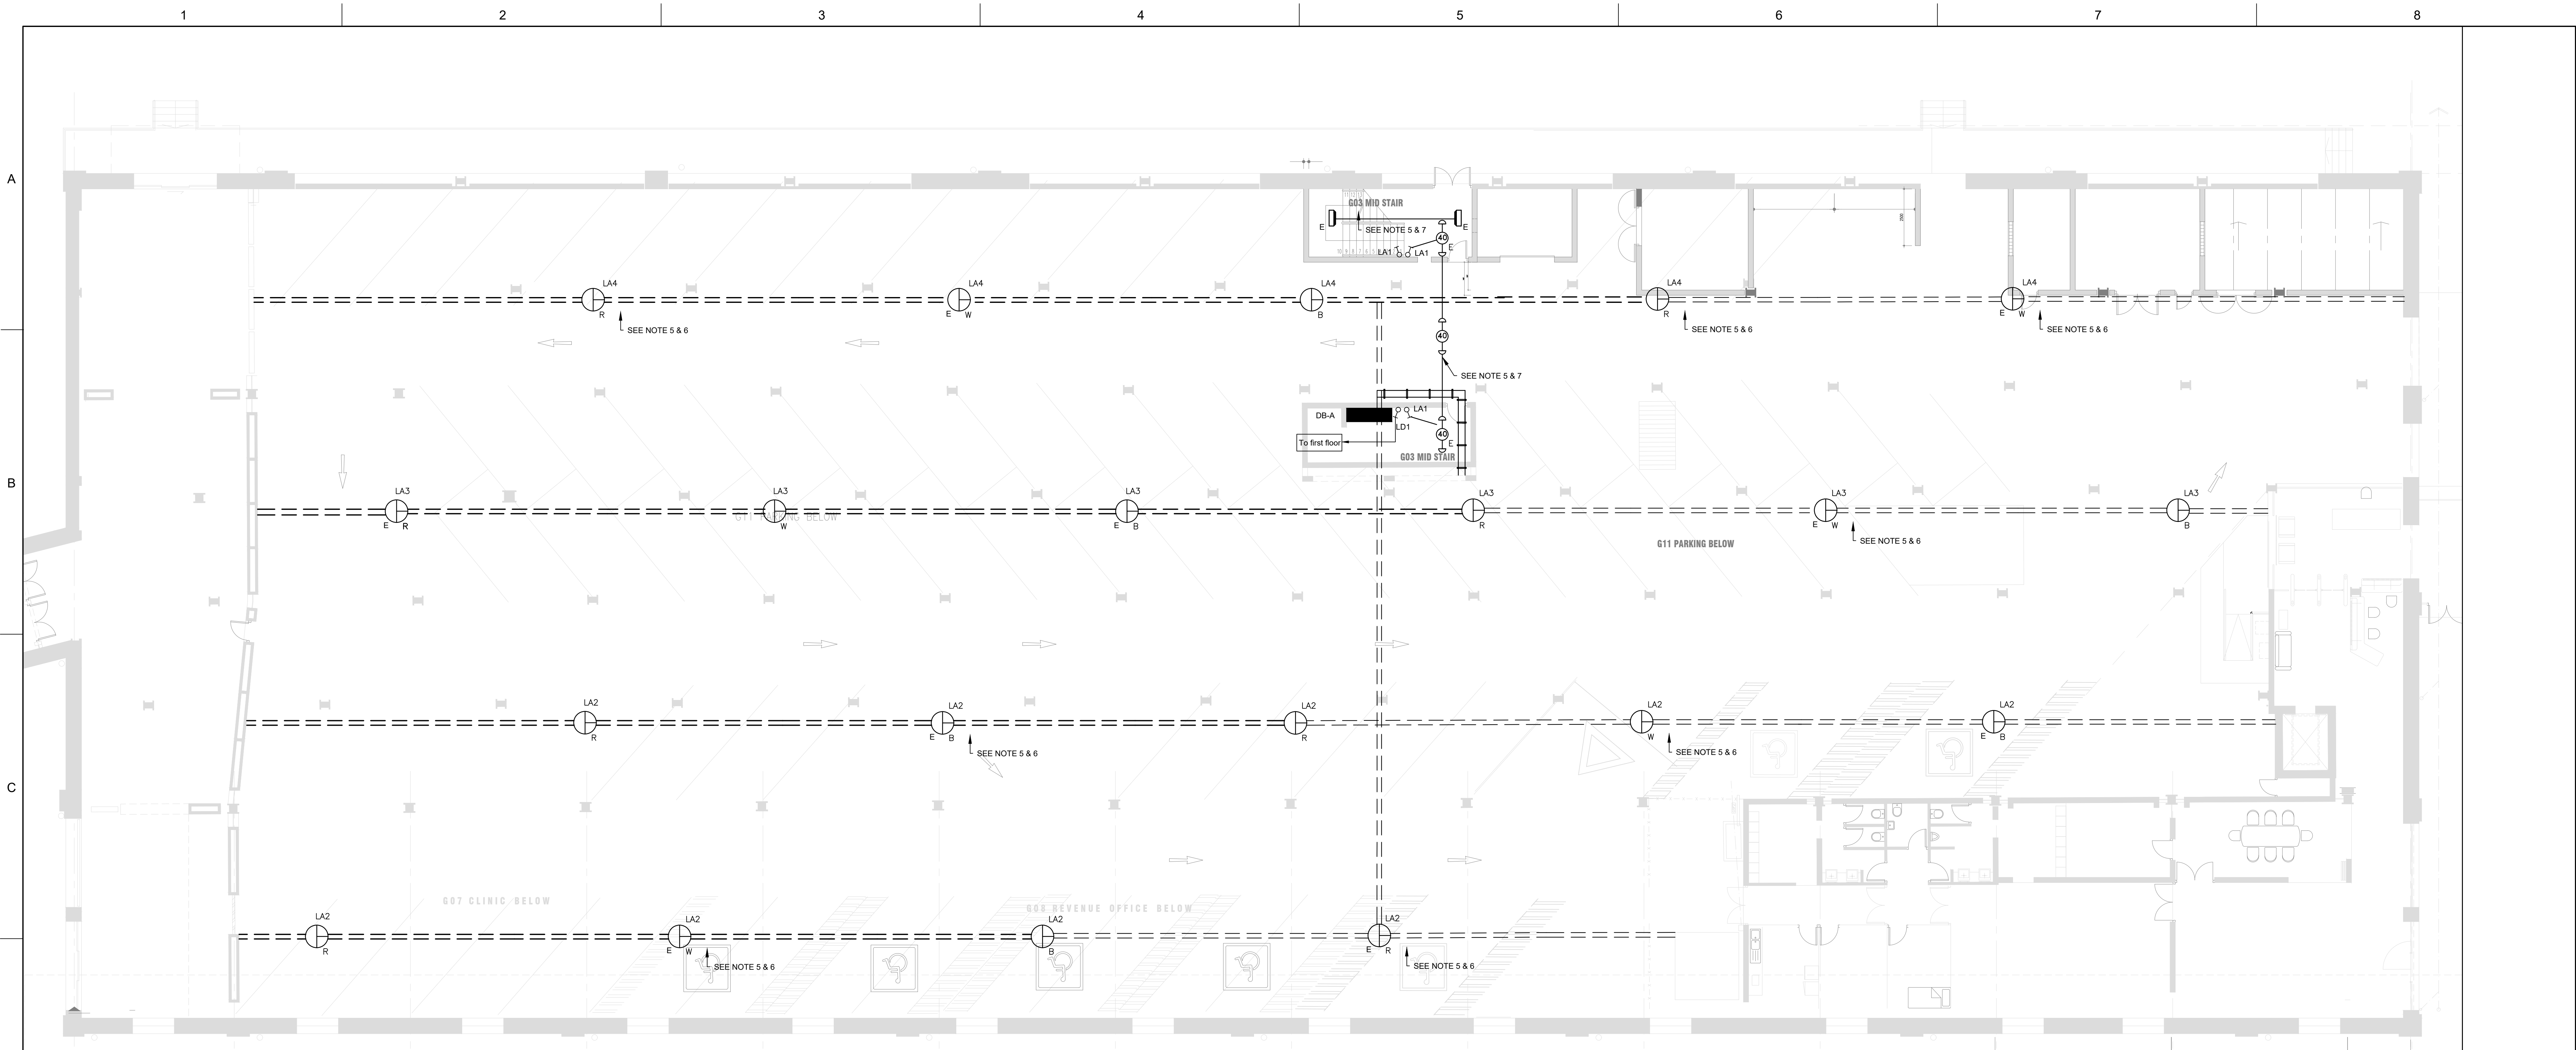

GROUND FLOOR PARKING LIGHTING LAYOUT
Scale 1:100

LEGEND		NOTES
		NOTES 1. THIS DRAWING IS FOR ELAP ONLY. 2. A CERTIFICATE OF COMPLIANCE TO BE COMPLETED BY CONTRACTOR ON COMPLETION OF WORK. 3. DO NOT SCALE DRAWING - ONLY DIMENSIONS SHOWN TO BE USED. 4. THE CONTRACTOR SHALL VERIFY ALL CONDITIONS, DIMENSIONS AND LEVELS ON THE SITE AND NOTIFY THE NEC SUPERVISOR OF ANY VARIATIONS BEFORE CONSTRUCTION. 5. ALL EXISTING LIGHTING CIRCUITS TO BE RETAINED AND RE-USED. 6. EXISTING UNISTRUIT IN THE PARKING AREA TO BE RETAINED AND RE-USED. 7. ALL STAIRCASE LIGHTING TO BE REPLACED AS PER EXISTING POSITIONING. 8. THE CONTRACTOR SHALL TEST AND VERIFY ALL ELECTRICAL CIRCUITS AT DB-A. THE CONTRACTOR SHALL ALSO RE-LABEL DB-A AND LABEL ALL SOCKET OUTLETS, ISOLATORS AND LIGHT SWITCHES INDICATING RELEVANT CIRCUIT NUMBERS.

DRAWING NO.	DRAWING DESCRIPTION
REFERENCE DRAWINGS	
1	
2	
3	
4	
5	
6	
7	
8	

- NOTES**
1. DO NOT SCALE DRAWING - ONLY DIMENSIONS SHOWN TO BE USED.
2. THE CONTRACTOR SHALL VERIFY ALL CONDITIONS, DIMENSIONS AND LEVELS ON THE SITE AND NOTIFY THE NEC SUPERVISOR OF ANY VARIATIONS BEFORE CONSTRUCTION.
3. ALL LEVELS ARE IN METERS TO MEAN SEA LEVEL

NO.	DESCRIPTION	ZD	PM	SS	DATE
REVISIONS					
This Document including all design and information therein is Confidential Intellectual Property of Transnet. Copyright and all other rights are reserved by Transnet. This Document may only be used for its intended purpose.					

PRIVATE OPERATOR LOGO

CONSULTANTS ENGINEERS LOGO

CONTRACTOR / CONSULTANT				TRANSNET NATIONAL PORTS AUTHORITY			
TITLE	NAME	SIGN	DATE	TITLE	NAME	SIGN	DATE
DRAWN				DRAWN	ZD	pp	19 09 25
CHECKED				CHECKED	PM	CS	19 09 25
DESIGNED				DESIGNED	ZD	pp	19 09 25
CHECKED				CHECKED	SS		19 09 25
PR. ENG. / PR. TECH. / PR. ARCH				PR. ENG. / PR. TECH. / PR. ARCH			
NAME	XX		DATE	NAME	SUDESH SEWDAVAL		DATE
SIGNATURE				SIGNATURE			27 07 26
REG. NUMBER	XXXXX			REG. NUMBER	200970129		
TITLE				TITLE			
SCALE	XX			PAPER SIZE			
TRANSNET DRG. NO.							

Transnet National Ports Authority


TRANSNET

REFURBISHMENT TO QUEENS WAREHOUSE
GROUND FLOOR
ELECTRICAL PARKING LIGHTING LAYOUT

PROJECT DRG. NO. XDN.E.0037 - 1 - 100 - E - LA - 0003 - 01

237 MAHATMA GANDHI ROAD
POINT, DURBAN
4001
PROJECT / AREA / ASSET / SUBJECT / DRAWING TITLE

TEL: 030 900 9000

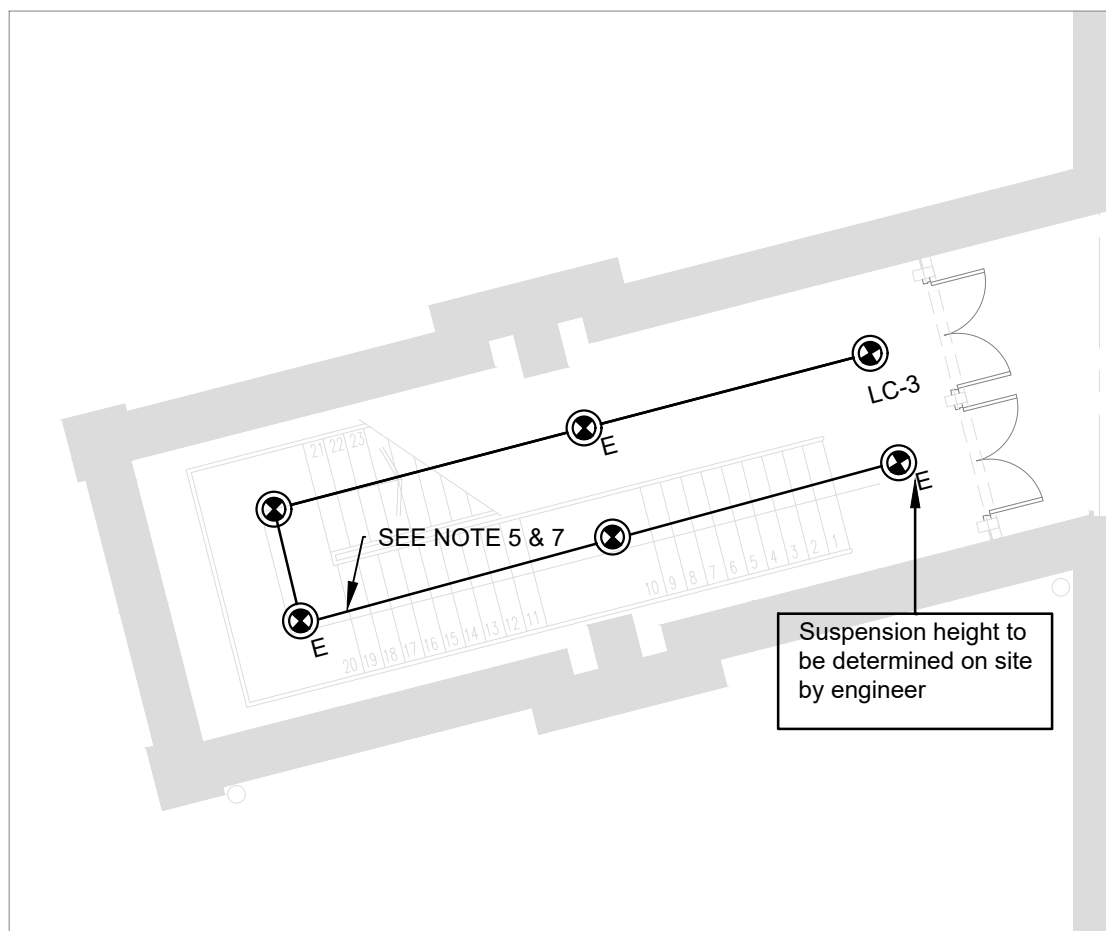

GROUND FLOOR SOUTH STAIRWELL LIGHTING LAYOUT
Scale 1:100