



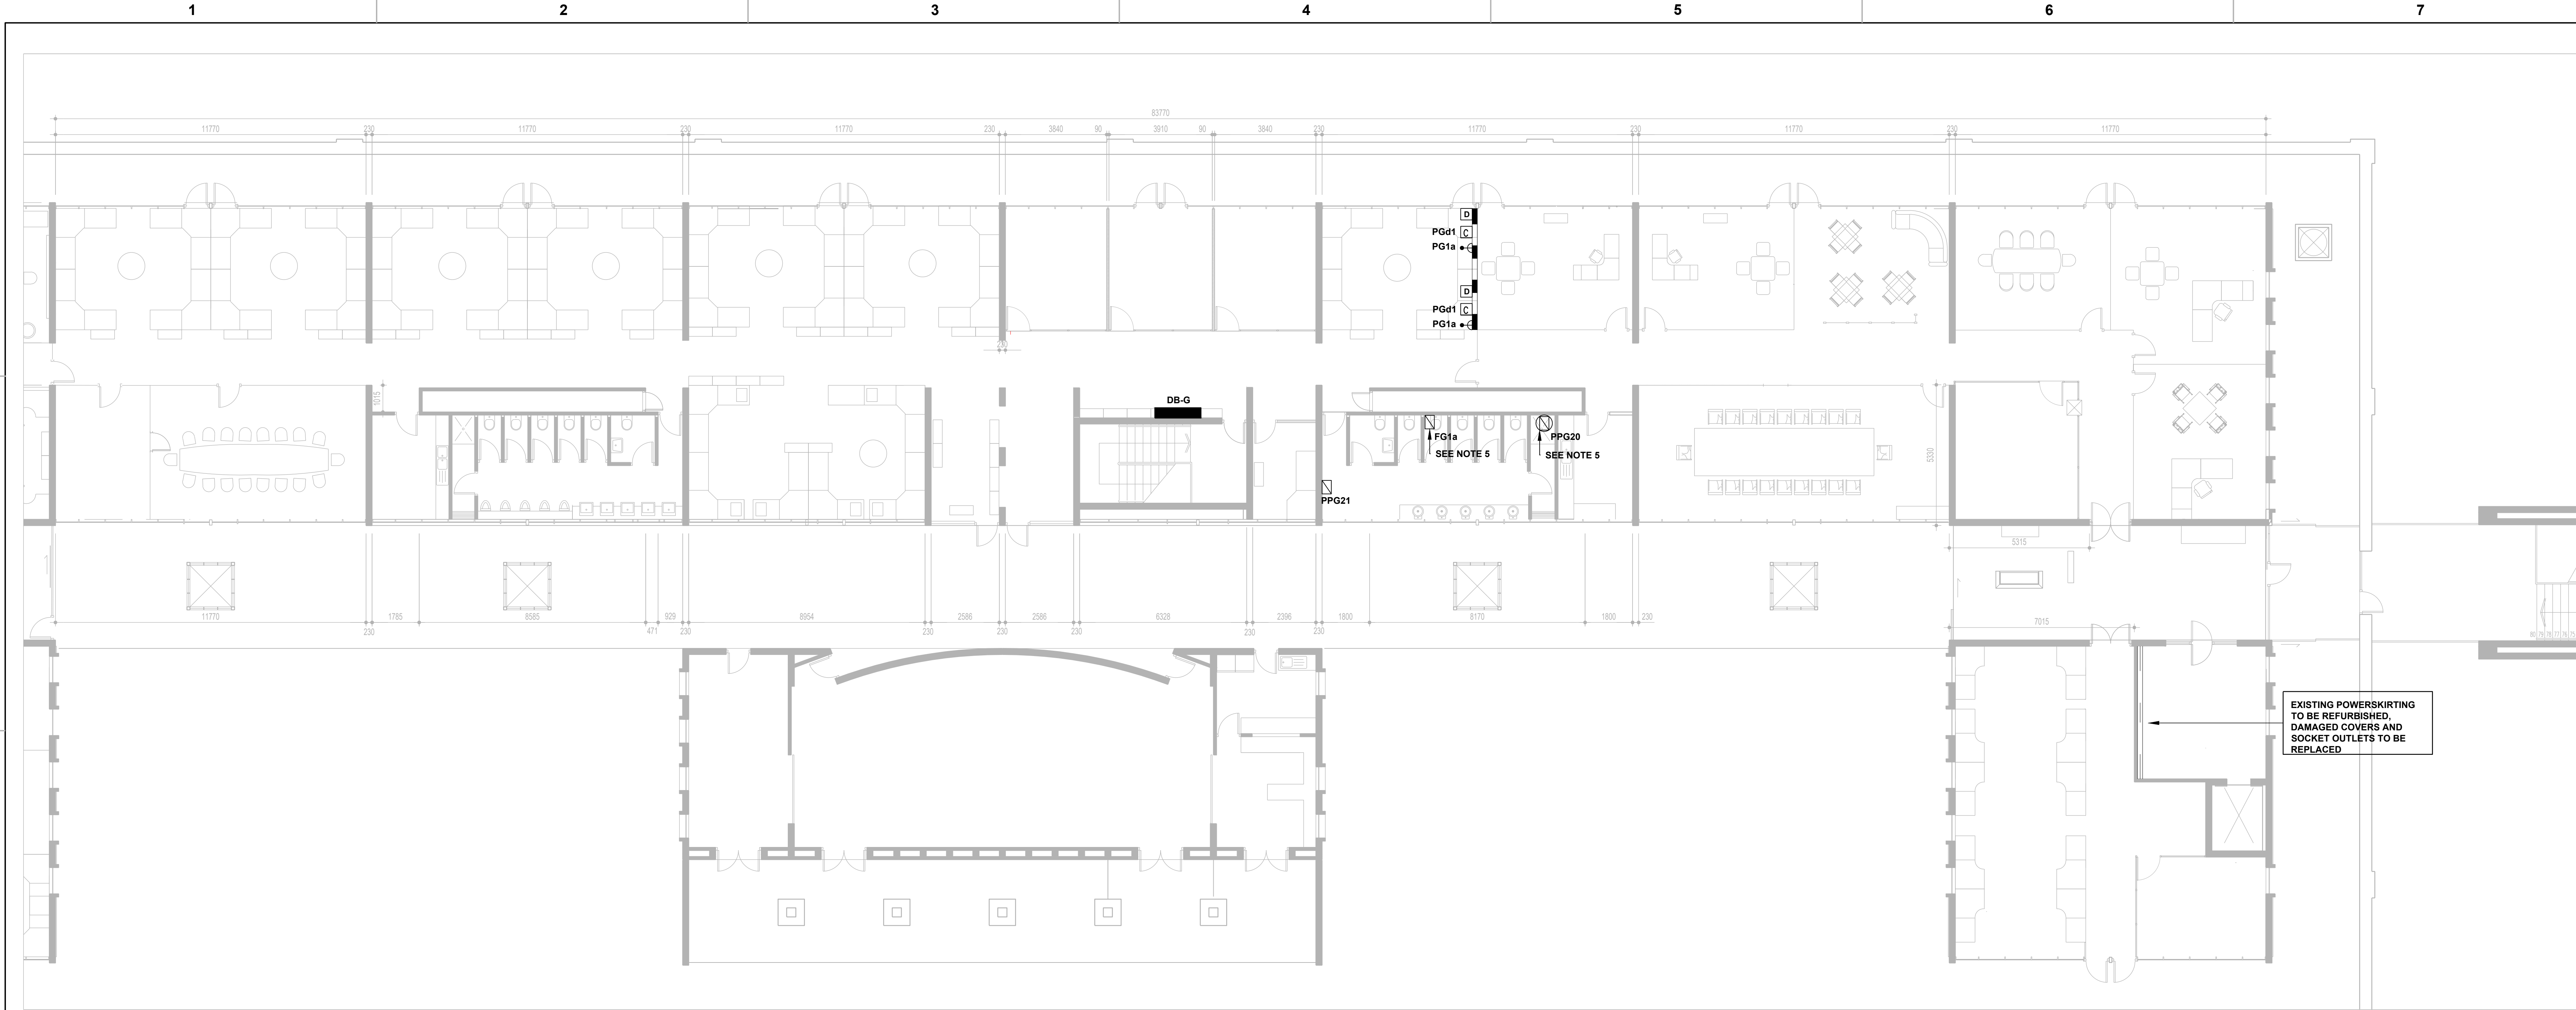

**SECOND FLOOR POWER LAYOUT**  
Scale 1:100

| LEGEND |                                                                                                                                                                                        |
|--------|----------------------------------------------------------------------------------------------------------------------------------------------------------------------------------------|
|        | 20A SINGLE PHASE ISOLATOR TO BE INSTALLED 2.2 m ABOVE FLOOR LEVEL TO COMPLY WITH TPD-A01-SDPERFSPEC                                                                                    |
|        | 20A SINGLE PHASE ISOLATOR (WEATHERPROOF) TO COMPLY WITH TPD-A04-ISOLATEPERSPEC                                                                                                         |
|        | ELECTRICAL DISTRIBUTION BOARD                                                                                                                                                          |
|        | 16A SINGLE SOCKET OUTLET (ON POWER SKIRTING) TO COMPLY WITH TPD-A01-SDPERFSPEC AND TPD-A03-PSKIRTPERSPEC                                                                               |
|        | 4X4 16A SWITCHED SINGLE FACILITY SINGLE PHASE SOCKET OUTLET (300mm ABOVE FLOOR LEVEL) GRAPHITE WITH 3 X SILIMLINE (16A-2) SOCKET AND 1 X RSA (16A-1) TO COMPLY WITH TPD-A01-SDPERFSPEC |
|        | TWO-TIER POWER SKIRTING (70mm2 data, 70mm2 power) TO COMPLY WITH TPD-A03-PSKIRTPERSPEC                                                                                                 |
|        | RJ45 POWER SKIRTING DATA OUTLET TO COMPLY WITH TPD-A01-SDPERFSPEC AND TPD-A03-PSKIRTPERSPEC                                                                                            |
|        | 4X2 GRAPHITE WITH 1 X DEDICATED SOCKET OUTLETS (300mm ABOVE FLOOR LEVEL ON POWER SKIRTING) TO COMPLY WITH TPD-A01-SDPERFSPEC AND TPD-A03-PSKIRTPERSPEC                                 |

| NOTES |                                                                                                                                                                                                               |
|-------|---------------------------------------------------------------------------------------------------------------------------------------------------------------------------------------------------------------|
| 1.    | THIS DRAWING IS FOR EL&P ONLY.                                                                                                                                                                                |
| 2.    | A CERTIFICATE OF COMPLIANCE TO BE COMPLETED BY CONTRACTOR ON COMPLETION OF WORK.                                                                                                                              |
| 3.    | DO NOT SCALE DRAWING - ONLY DIMENSIONS SHOWN TO BE USED.                                                                                                                                                      |
| 4.    | THE CONTRACTOR SHALL VERIFY ALL CONDITIONS, DIMENSIONS AND LEVELS ON THE SITE AND NOTIFY THE NEC SUPERVISOR OF ANY VARIATIONS BEFORE CONSTRUCTION.                                                            |
| 5.    | ALL EXISTING PLUG AND ISOLATOR CIRCUITS SHALL BE RETAINED AND RE-USED.                                                                                                                                        |
| 6.    | THE CONTRACTOR SHALL TEST AND VERIFY ALL ELECTRICAL CIRCUITS AT DB-G. THE CONTRACTOR SHALL ALSO RE-LABEL DB-G AND LABEL ALL SOCKET OUTLETS, ISOLATORS AND LIGHT SWITCHES INDICATING RELEVANT CIRCUIT NUMBERS. |

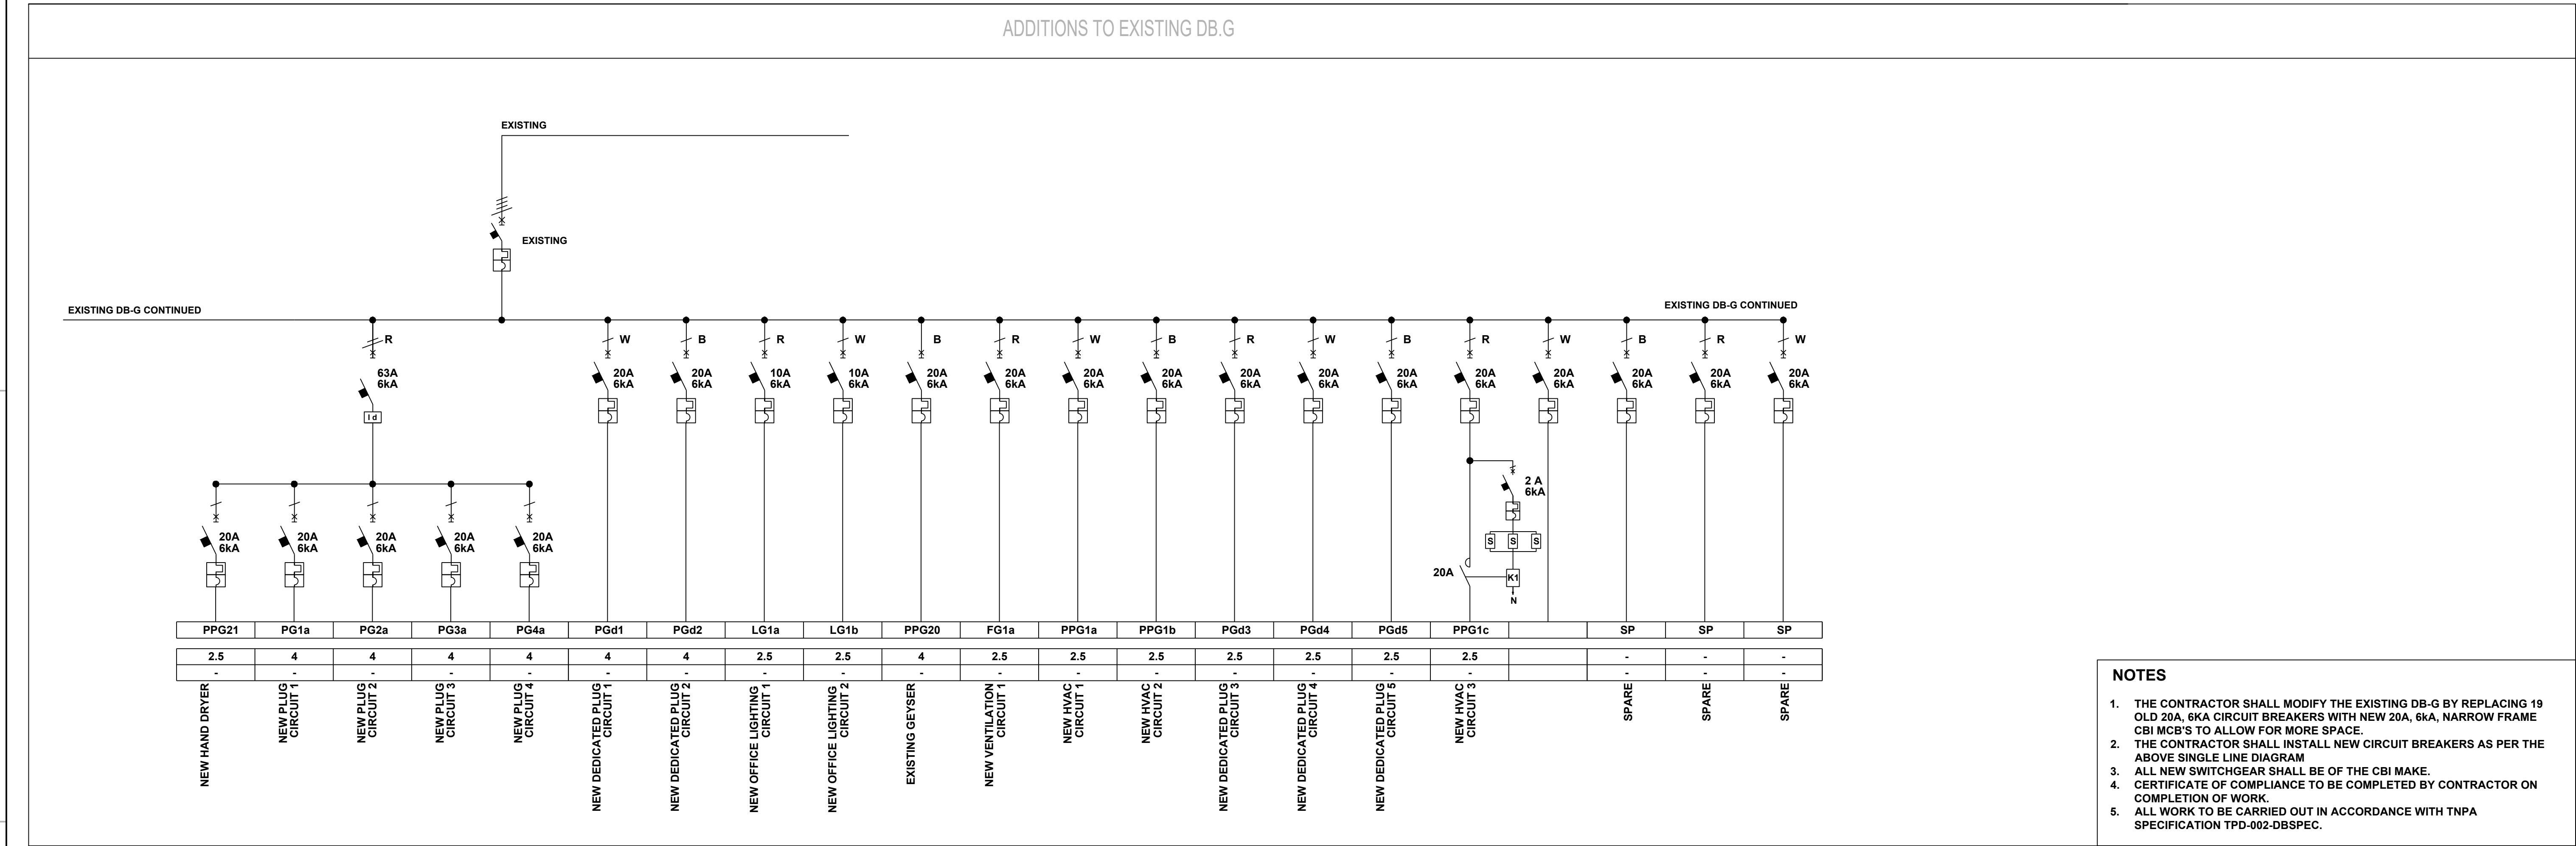

| DRAWING NO.        | DRAWING DESCRIPTION |
|--------------------|---------------------|
| REFERENCE DRAWINGS |                     |

| NOTES |                                                                                                                                                    |
|-------|----------------------------------------------------------------------------------------------------------------------------------------------------|
| 1.    | DO NOT SCALE DRAWING - ONLY DIMENSIONS SHOWN TO BE USED.                                                                                           |
| 2.    | THE CONTRACTOR SHALL VERIFY ALL CONDITIONS, DIMENSIONS AND LEVELS ON THE SITE AND NOTIFY THE NEC SUPERVISOR OF ANY VARIATIONS BEFORE CONSTRUCTION. |
| 3.    | ALL LEVELS ARE IN METERS TO MEAN SEA LEVEL.                                                                                                        |

| REVISIONS |                   |
|-----------|-------------------|
| NO.       | DESCRIPTION       |
| 1         | ISSUED FOR TENDER |
| 2         | BY                |
| 3         | CHKD              |
| 4         | APPD              |
| 5         | DATE              |
| 6         | 27 07 2026        |

| CONTRACTOR / CONSULTANT     |       | TRANSNET NATIONAL PORTS AUTHORITY |                 | Transnet National Ports Authority         |                 |
|-----------------------------|-------|-----------------------------------|-----------------|-------------------------------------------|-----------------|
| TITLE                       | NAME  | SIGN                              | DATE            | TITLE                                     | NAME            |
| DRAWN                       | XX    |                                   |                 | DRAWN                                     | SD              |
| CHECKED                     |       |                                   |                 | CHECKED                                   | PM              |
| DESIGNED                    |       |                                   |                 | DESIGNED                                  | SD              |
| CHECKED                     |       |                                   |                 | CHECKED                                   | SS              |
| PR.ENG. / PR.TECH./PR. ARCH |       | PR.ENG. / PR.TECH./PR. ARCH       |                 | PR.ENG. / PR.TECH./PR. ARCH               |                 |
| NAME                        | XX    | NAME                              | SUDESH SEWDAYAL | NAME                                      | SUDESH SEWDAYAL |
| SIGNATURE                   |       | SIGNATURE                         |                 | SIGNATURE                                 |                 |
| REG. NUMBER                 | XXXXX | REG. NUMBER                       | 200970129       | REG. NUMBER                               | 200970129       |
| TITLE                       |       | TITLE                             |                 | TITLE                                     |                 |
| SCALE                       | XX    | PAPER SIZE                        | A0              | PAPER SIZE                                | A0              |
| TRANSNET DRG. NO.           |       | PROJECT DRG. NO.                  |                 | XDN.E.0037 - 1 - 100 - E - LA - 2002 - 01 |                 |
| CONSULTANTS ENGINEERS LOGO  |       | PRIVATE OPERATOR LOGO             |                 | PORT OF DURBAN                            |                 |
|                             |       |                                   |                 | REFURBISHMENT TO QUEENS WAREHOUSE         |                 |
|                             |       |                                   |                 | SECOND FLOOR                              |                 |
|                             |       |                                   |                 | ELECTRICAL POWER LAYOUT                   |                 |
|                             |       |                                   |                 | REV. E                                    |                 |