



 LIGHTING LAYOUT PLAN
SECOND STOREY PLAN
 SCALE 1:50

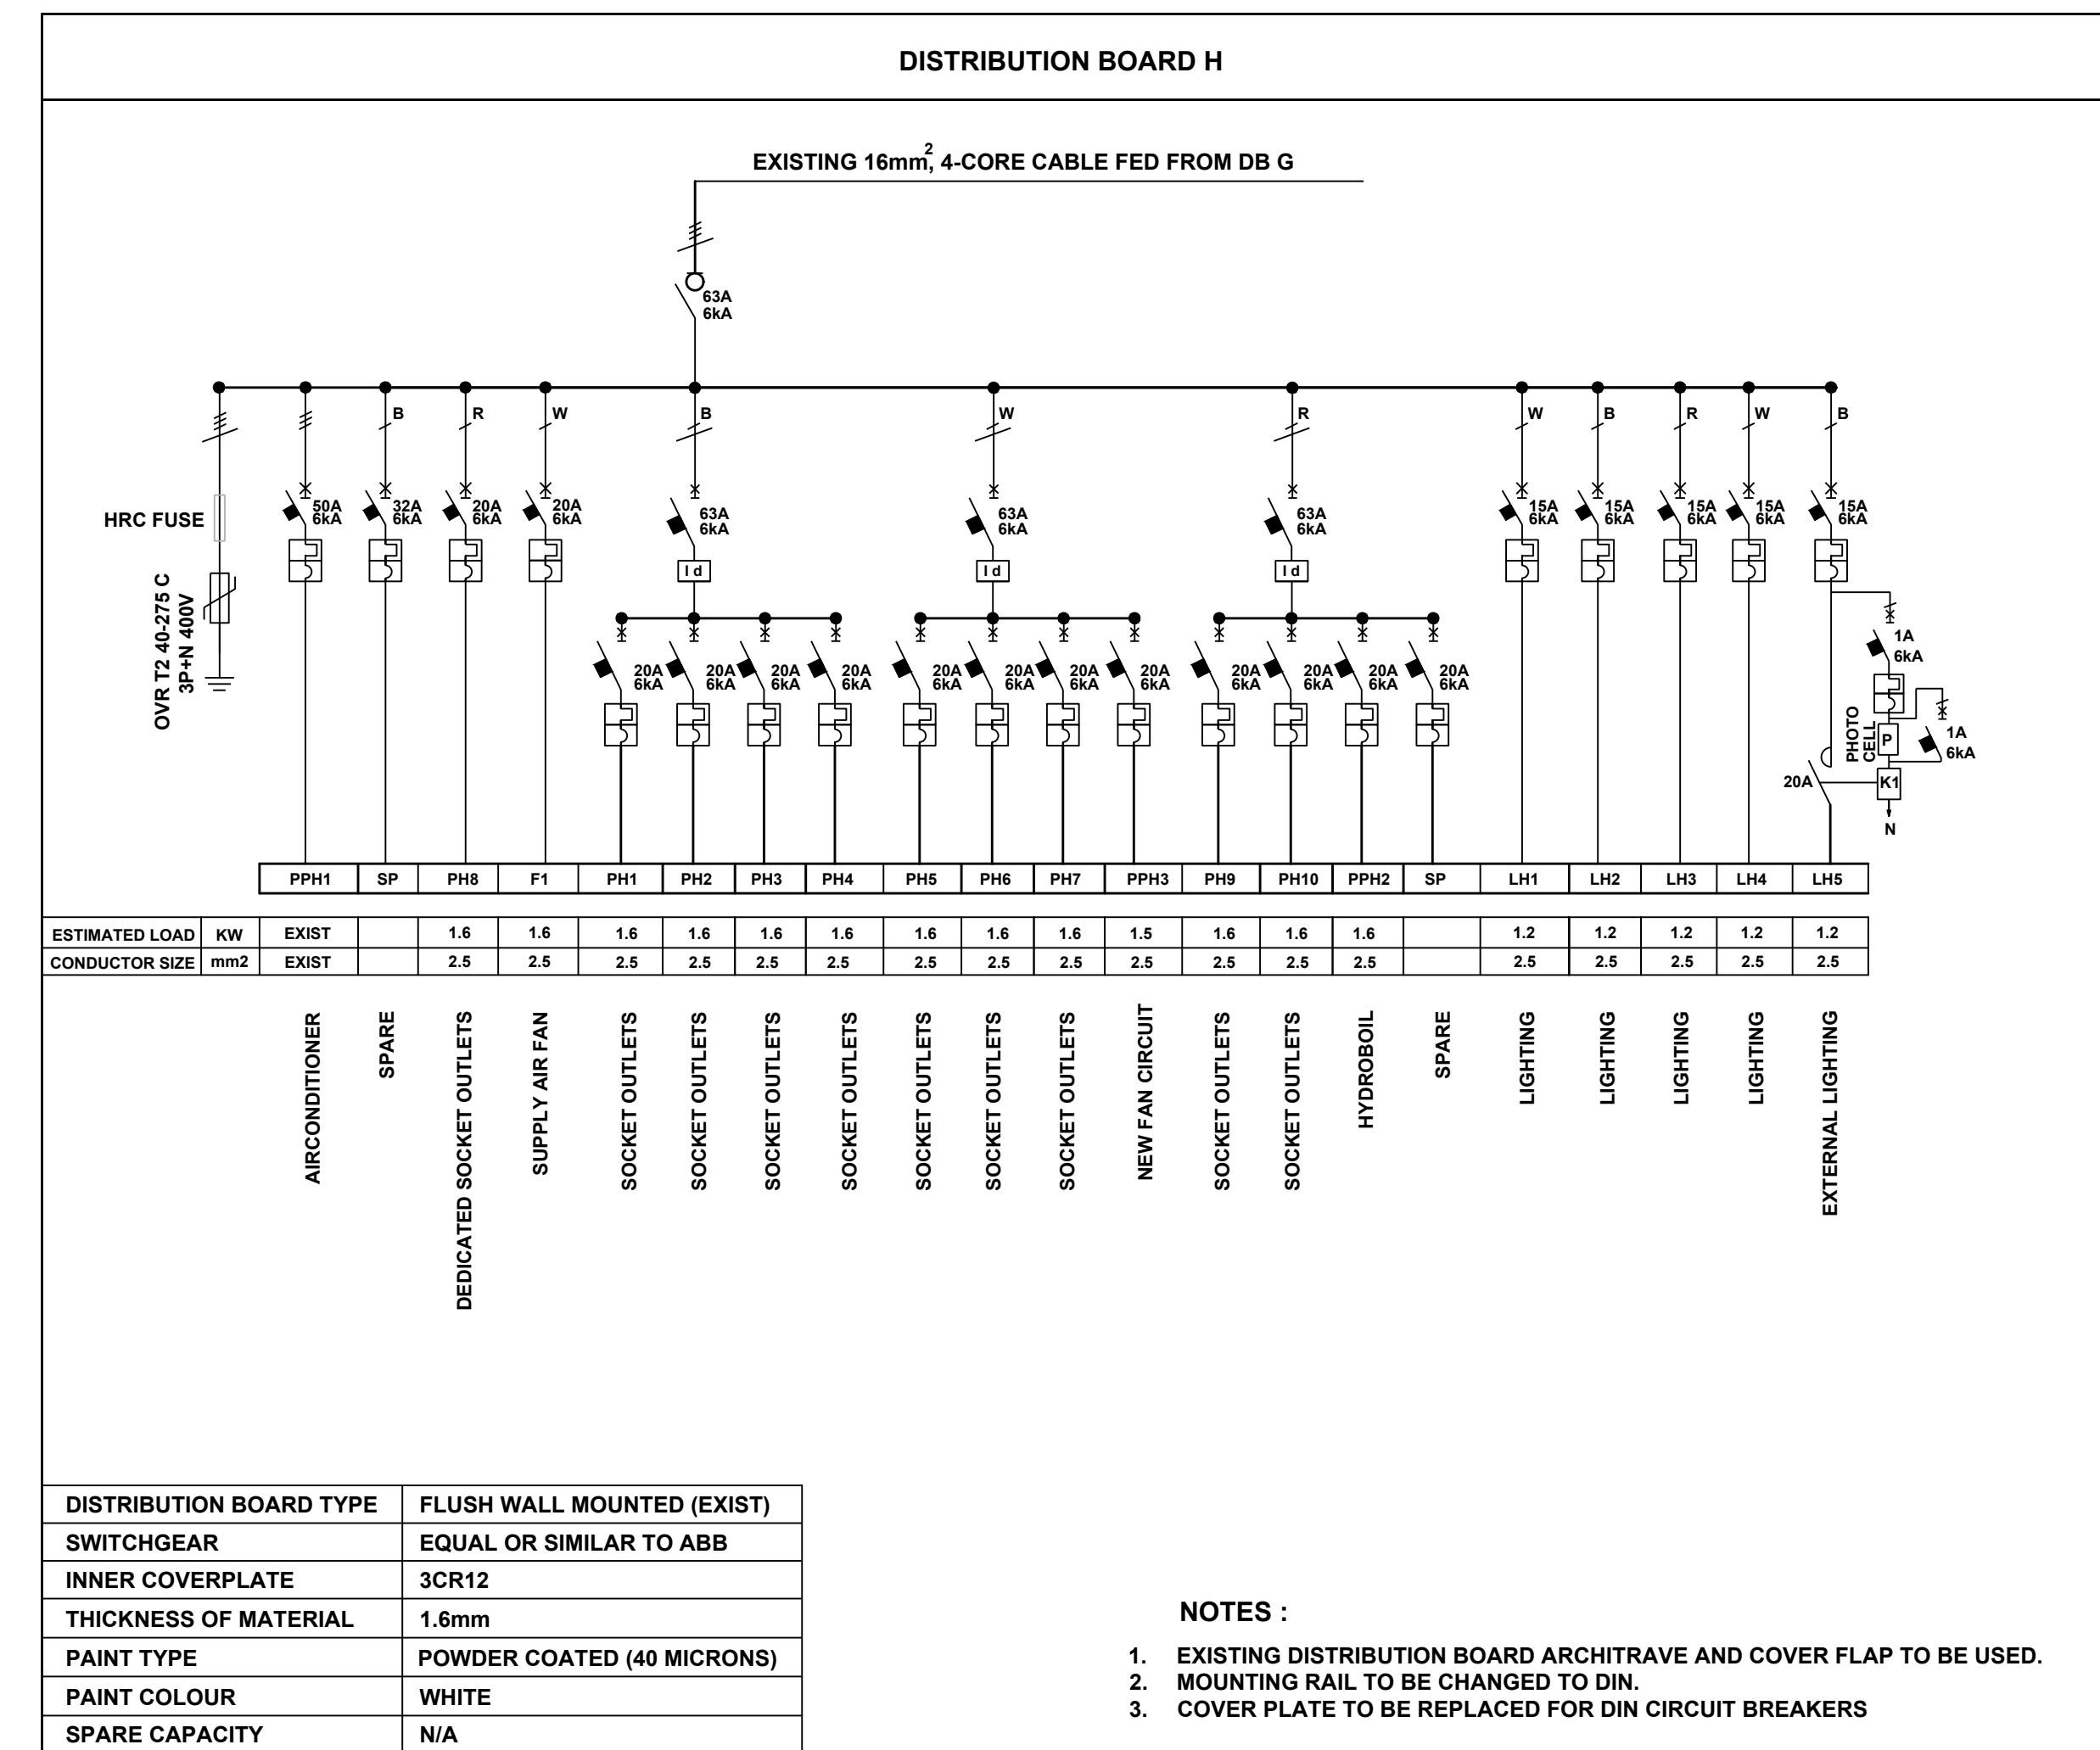

POWER LAYOUT PLAN
SECOND STOREY PLAN
SCALE 1:50

4X4 16A SWITCHED SINGLE FACILITY SINGLE PHASE SOCKET OUTLET (135mm ABOVE FLOOR LEVEL) GRAPHITE WITH 1 X SILIMLINE (164-2) SOCKET AND 1 X RSA (164-1) TO COMPLY WITH TPD-A01-SDPERFSPEC 4X4 16A SWITCHED SINGLE FACILITY SINGLE PHASE SOCKET OUTLET (300mm ABOVE FLOOR LEVEL) GRAPHITE WITH 1 X SILIMLINE (164-2) SOCKET AND 1 X RSA (164-1) TO COMPLY WITH TPD-A01-SDPERFSPEC 4X2 16A SWITCHED SINGLE FACILITY SINGLE PHASE SOCKET OUTLET INSTALLED ON POWER SKIRTING TO COMPLY WITH TPD-A01-SDPERFSPEC AND TPD-A05-PSKIRTERFSPEC 4X4 GRAPHITE SOCKET OUTLET WITH 3 X RJ45 MODULES (300mm ABOVE FLOOR LEVEL) TO COMPLY WITH TPD-A01-SDPERFSPEC 20A SINGLE-PHASE GRAPHITE CORD GRIP ISOLATOR TO COMPLY WITH TPD-A01-SDPERFSPEC PVC POWER SKIRTING (COLOUR - TBA) TO COMPLY WITH TPD-A03-PSKIRTERFSPEC DISTRIBUTION BOARD	30W, 4000K, RECESSED 600x600mm LUMINAIRE WITH INTEGRATED OCCUPANCY SENSOR TO CONFORM WITH TPD-A11-LUM01PERFSPEC 30W, 4000K, EMG 15MIN, RECESSED 600x600mm LUMINAIRE WITH INTEGRATED OCCUPANCY SENSOR TO CONFORM WITH TPD-A11-LUM01PERFSPEC 29W, 4000K, LARGE RECESSED DOWNLIGHTER TO CONFORM WITH TPD-A09-LUM02PERFSPEC 7W, 4000K, BLACK MINI RECESSED DOWNLIGHTER TO CONFORM WITH TPD-A09-LUM02PERFSPEC 7W, 4000K, EMG 15MIN, BLACK MINI RECESSED DOWNLIGHTER TO CONFORM WITH TPD-A09-LUM02PERFSPEC 12W, 4000K, DECORATIVE PENDANT LUMINAIRE TO CONFORM WITH TPD-A16-LUM04PERFSPEC. TO BE SUSPENDED 0.5m FROM CEILING 21W, 4000K, WALL MOUNTED BULKHEAD WITH BLACK TRIM TO CONFORM WITH TPD-A07-LUM03PERFSPEC STRIPLIGHT WITH DIMMABLE LED DRIVER INSTALLED IN CORNER ALUMINIUM PROFILE AND ANOD ALCOVER TO CONFORM WITH TPD-A13-LUM01PERFSPEC ONE LEVER ONE WAY LIGHT SWITCH, 4X2 GRAPHITE TO COMPLY WITH TPD-A01-SDPERFSPEC TWO LEVER TWO WAY LIGHT SWITCH, 4X2 GRAPHITE TO COMPLY WITH TPD-A01-SDPERFSPEC FOUR LEVER TWO WAY LIGHT SWITCH, 4X2 GRAPHITE TO COMPLY WITH TPD-A01-SDPERFSPEC 16A DIMMER LIGHT SWITCH, 4X2 GRAPHITE TO COMPLY WITH TPD-A01-SDPERFSPEC
--	---

- NOTES :**
- 1. THIS DRAWING FOR ELECTRICAL LIGHTING & POWER ONLY.**
 - 2. A CERTIFICATE OF COMPLIANCE TO BE COMPLETED AND SUBMITTED BY THE CONTRACTOR ON COMPLETION OF WORK.**
 - 3. ELECTRICAL, DATA AND COMMS AND FIRE SUB- CONTRACTORS TO CO-ORDINATE ALL REQUIREMENTS FOR WIREWAYS, CONDUIT AND OTHER SERVICES THAT ASSOCIATED WITH THE EQUIPMENT (CONTRACTORS DESIGN).**
 - 4. ALL WORK MUST COMPLY WITH THE GENERAL REQUIREMENTS OF SANS 10142-1 (as amended).**
 - 5. ALL ALTERNATIVES (OR SIMILAR) OF EQUIPMENT AND FIXTURES TO BE APPROVED BY THE ELECTRICAL ENGINEER PRIOR TO ORDERING.**

- NOTES**
1. DO NOT SCALE DRAWING - ONLY DIMENSIONS SHOWN TO BE USED
 2. THE CONTRACTOR SHALL VERIFY ALL CONDITIONS, DIMENSIONS AND LEVELS ON THE SITE AND NOTIFY THE NEC SUPERVISOR OF ANY VARIATIONS BEFORE CONSTRUCTION.
 3. ALL LEVELS ARE IN METERS TO MEAN SEA LEVEL

[illegible]