




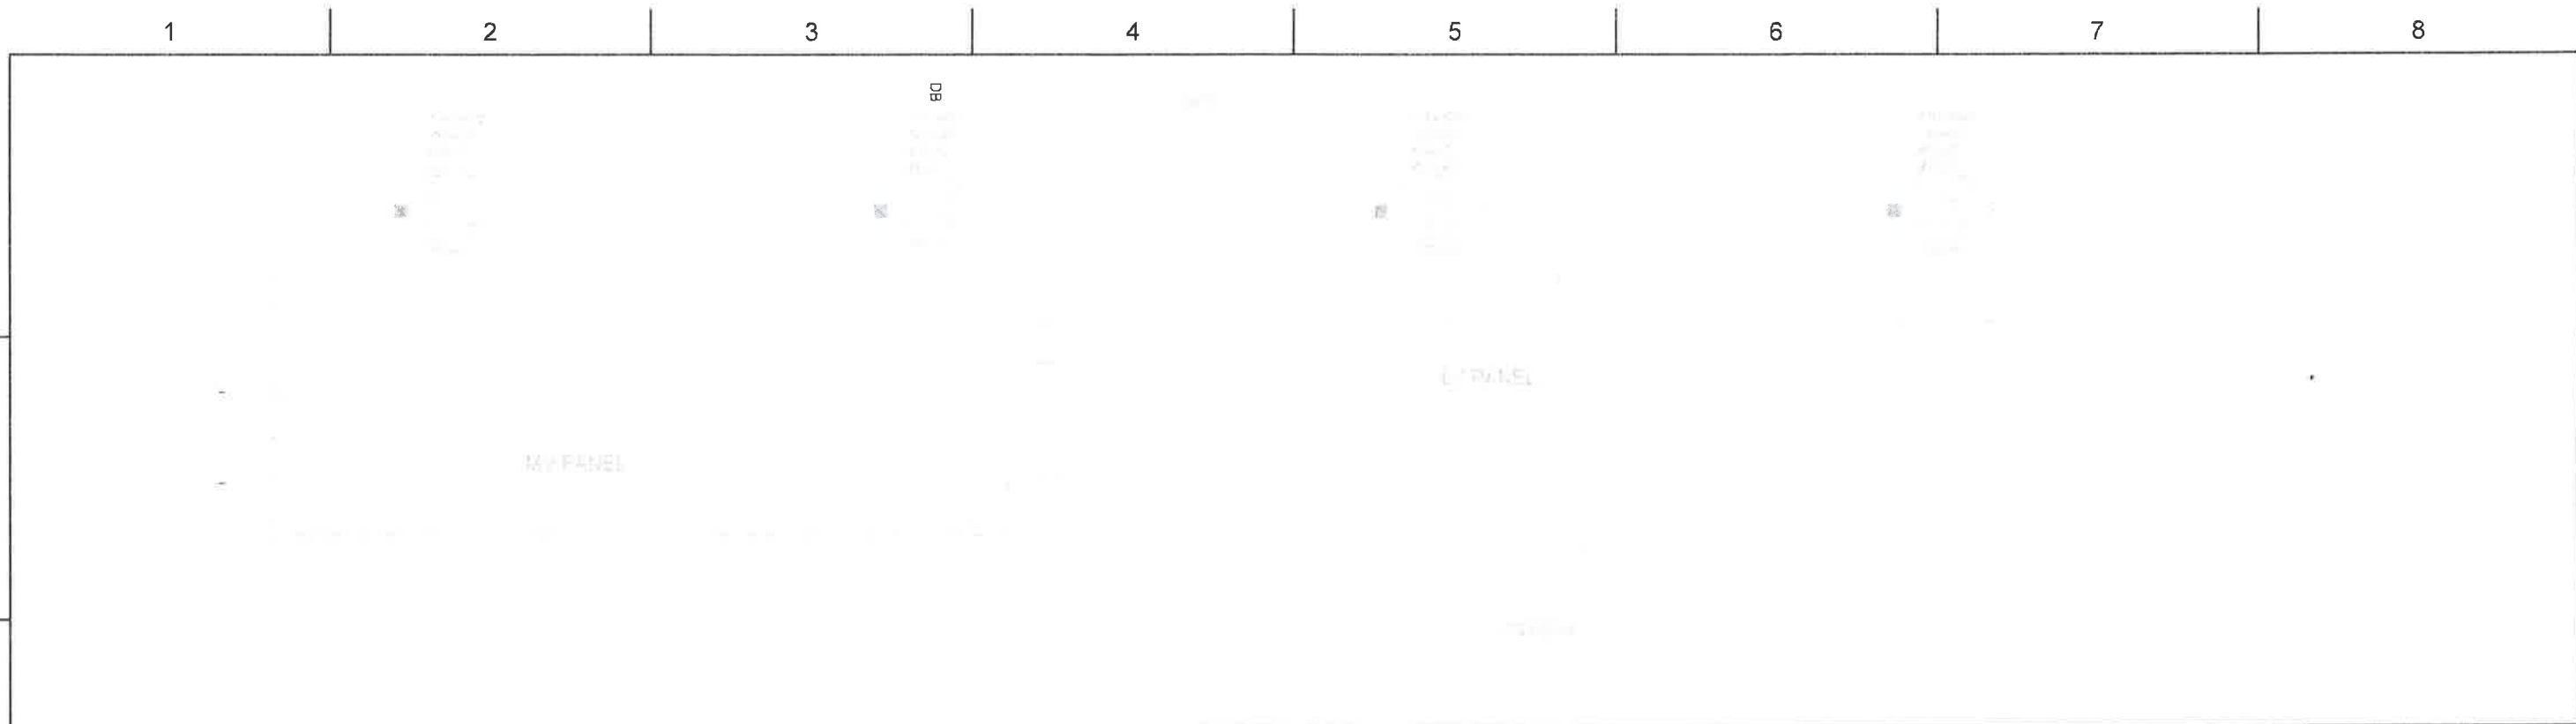

FLOOR PLAN LAYOUT
SCALE 1:100

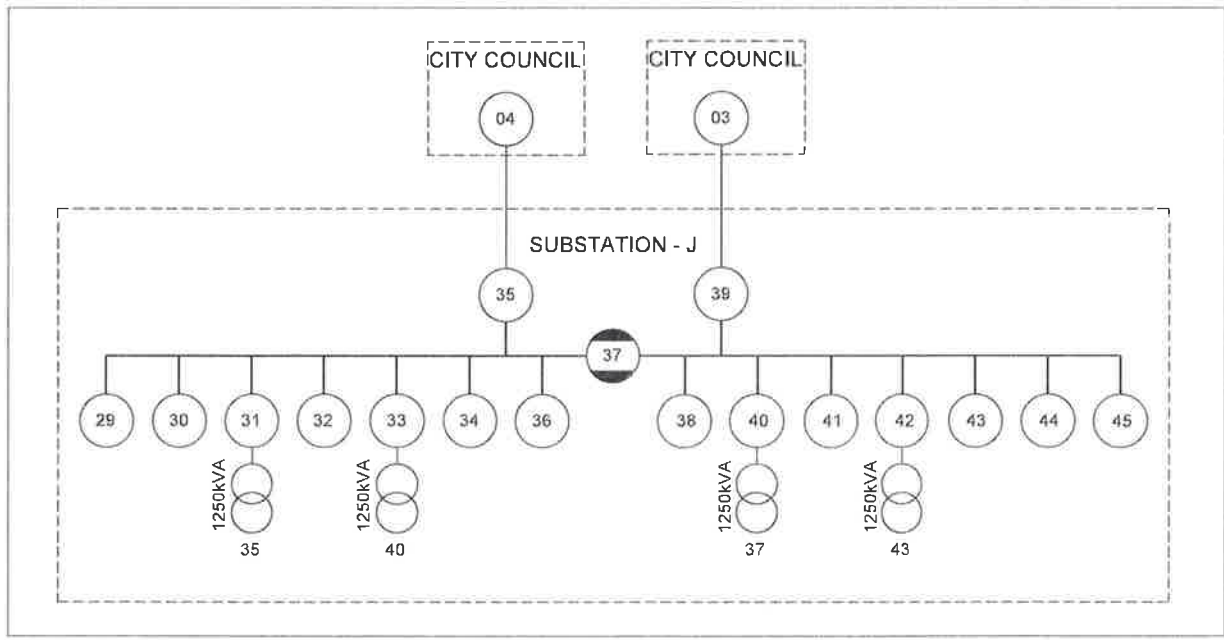

PROPOSED MEDIUM VOLTAGE SINGLE LINE DIAGRAM
SCALE 1:100

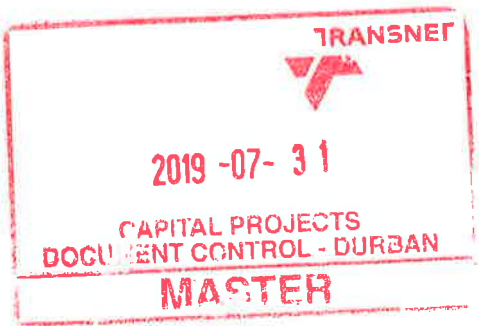

NOTES
1. DO NOT SCALE DRAWING - ONLY DIMENSIONS SHOWN TO BE USED.
2. THE CONTRACTOR SHALL VERIFY ALL CONDITIONS, DIMENSIONS AND LEVELS ON THE SITE AND NOTIFY THE NEC SUPERVISOR OF ANY VARIATIONS BEFORE CONSTRUCTION.

DRAWING NO.	REFERENCE
REFERENCE DRAWINGS	

REVISIONS					
NO.	DESCRIPTION	BY	CHKD	APPD	DATE
0A	ISSUED FOR TENDER	PM	KZ	LP	26-07-2019
1	ISSUED FOR INTERNAL REVIEW	PM	KZ	LP	28-05-2019

This Document including all design and information therein is Confidential Intellectual Property of Transnet.
Copyright and all other rights are reserved by Transnet. This Document may only be used for its intended purpose.

CONTRACTOR / CONSULTANT			
TITLE	NAME	SIGN	DATE

OPERATING DIVISIONS			
TITLE	NAME	SIGN	DATE

TRANSNET CAPITAL PROJECTS			
TITLE	NAME	SIGN	DATE
DRAWN	KZ	[Signature]	26 07 19
CHECKED	PM	[Signature]	26 07 19
DESIGNED	KZ	[Signature]	26 07 19
CHECKED	PM	[Signature]	26 07 19

PR.ENG. / PR.TECH./PR. ARCH		
NAME	SIGNATURE	DATE
SUDESEWDAYAL	[Signature]	26 07 19
REG. NUMBER	200970128	
SCALE	AS SHOWN	

Transnet Capital Projects

TRANSNET LTD (TRADING AS TRANSNET CAPITAL PROJECTS) REG. NO 1990/00090005
237 MAHATMA GANDHI ROAD
DURBAN
P.O. BOX 1073 DURBAN

TEL: 031 361 1696
FAX: 0866 770815

TRANSNET

KOEDOESPOORT

**UPGRADE OF ELECTRICAL SUBSTATION
EQUIPMENT AT TE FACILITIES
11kV SUBSTATION - J
EXISTING MV SINGLE LINE DIAGRAM AND
FLOOR PLAN**

PROJECT NUMBER	OD	FBS	DIS	TYPE	DRAWING NO	SHEET	REV	ID
2 5 3 7 8 4 2 - 5 - 0 0 4 - E - L A - 0 0 0 5 - 0 1 - O A	TD							